


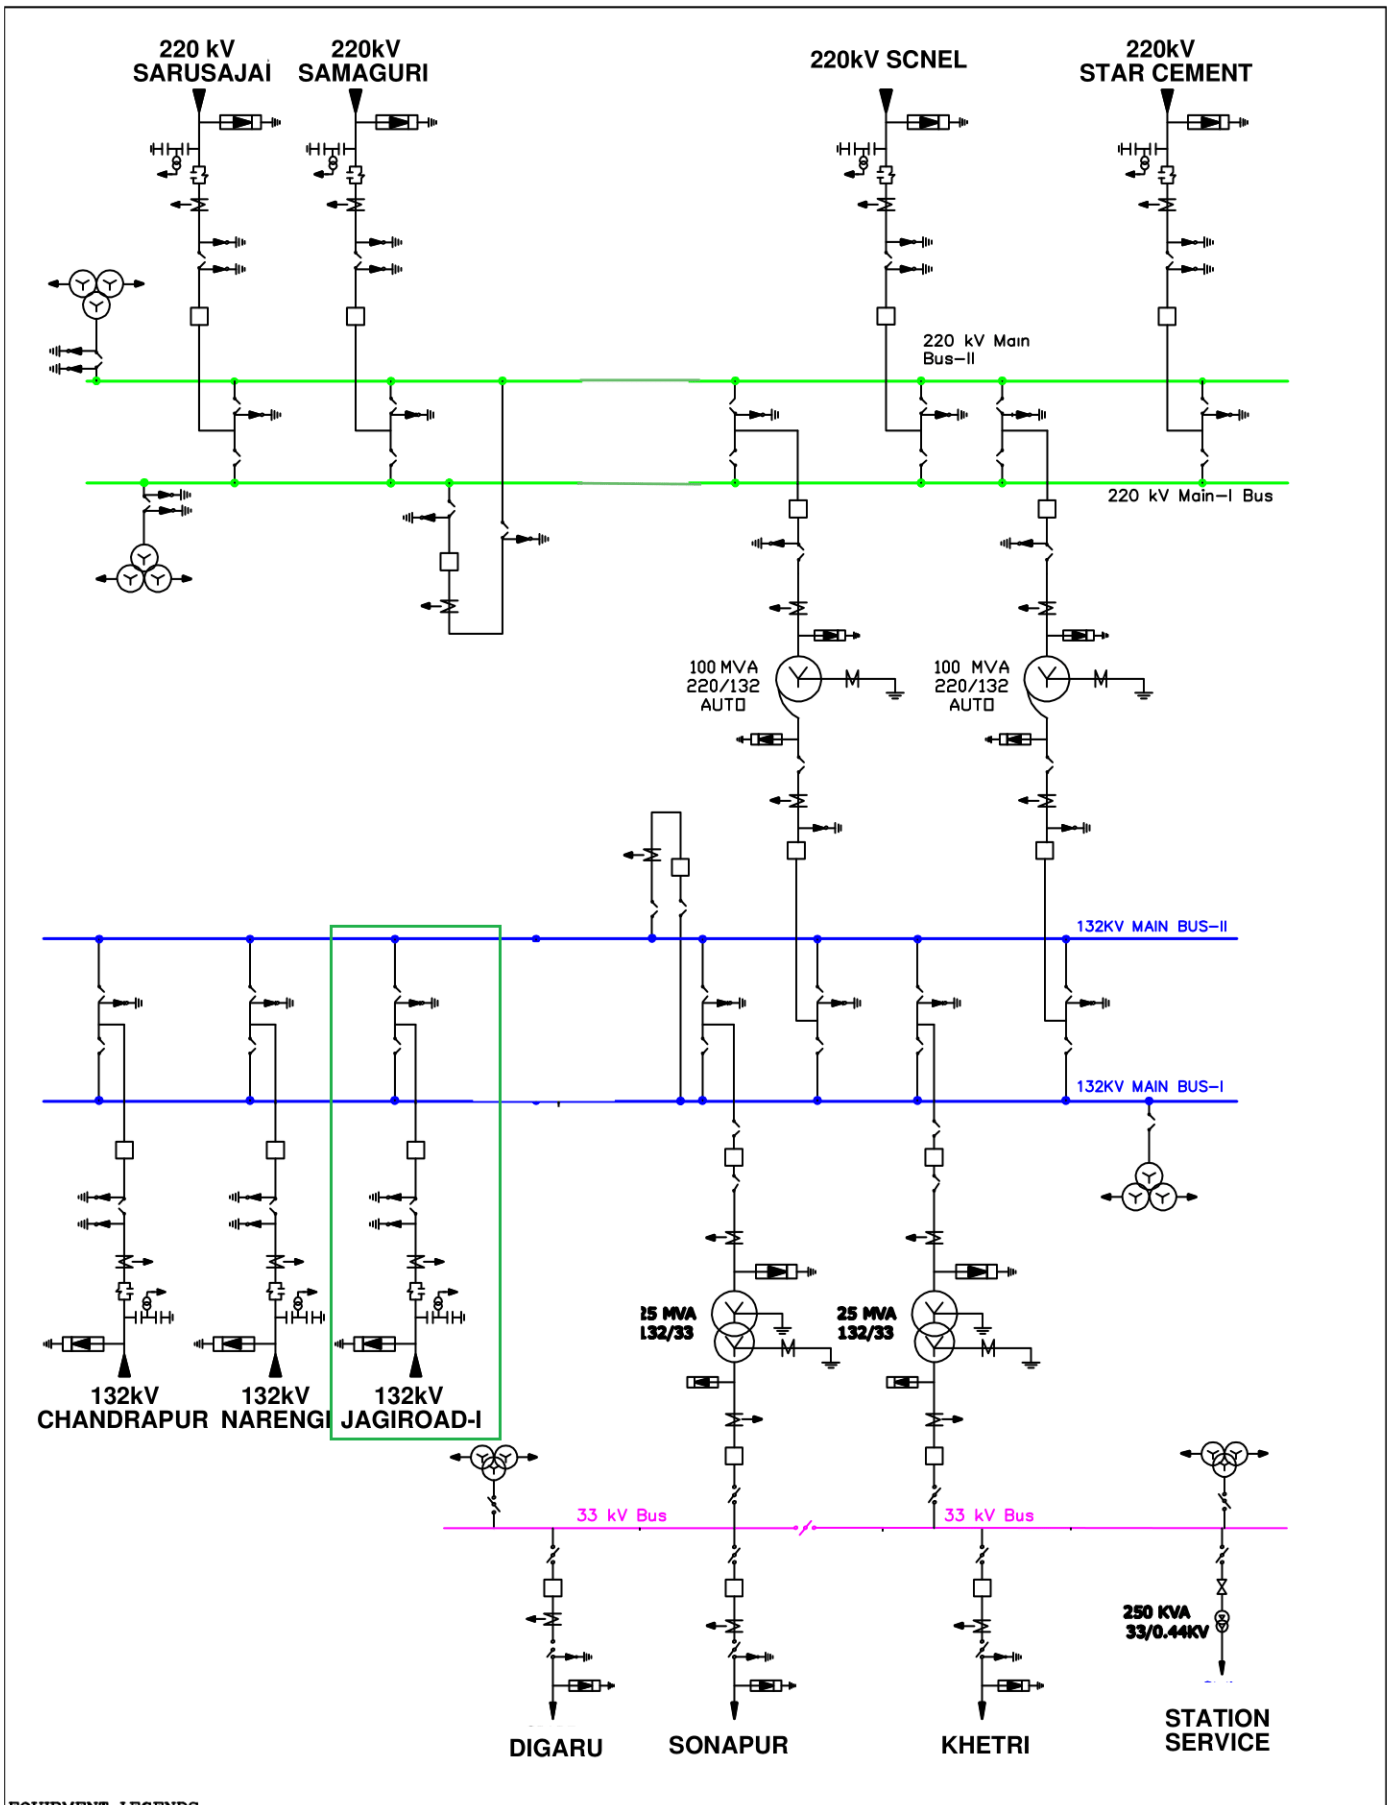

EQUIPMENT LEGENDS

POWER TRANSFORMER	CIRCUIT BREAKER	ISOLATOR WITHOUT EB	ISOLATOR WITH EB	CURRENT TRANSFORMER	POTENTIAL TRANSFORMER	LIGHTNING ARRESTER	WAVE TRAP	OT



ASSAM ELECTRICITY GRID CORPORATION LIMITED

220/132/33 KV, SONAPUR GIS SUBSTATION

SINGLE LINE DIAGRAM OF 220/132/33 KV, SONAPUR GIS SUBSTATION

DRAWING NO.: AEGCL/SONAPUR/SLD/63

Sheet: 1 OF 1