



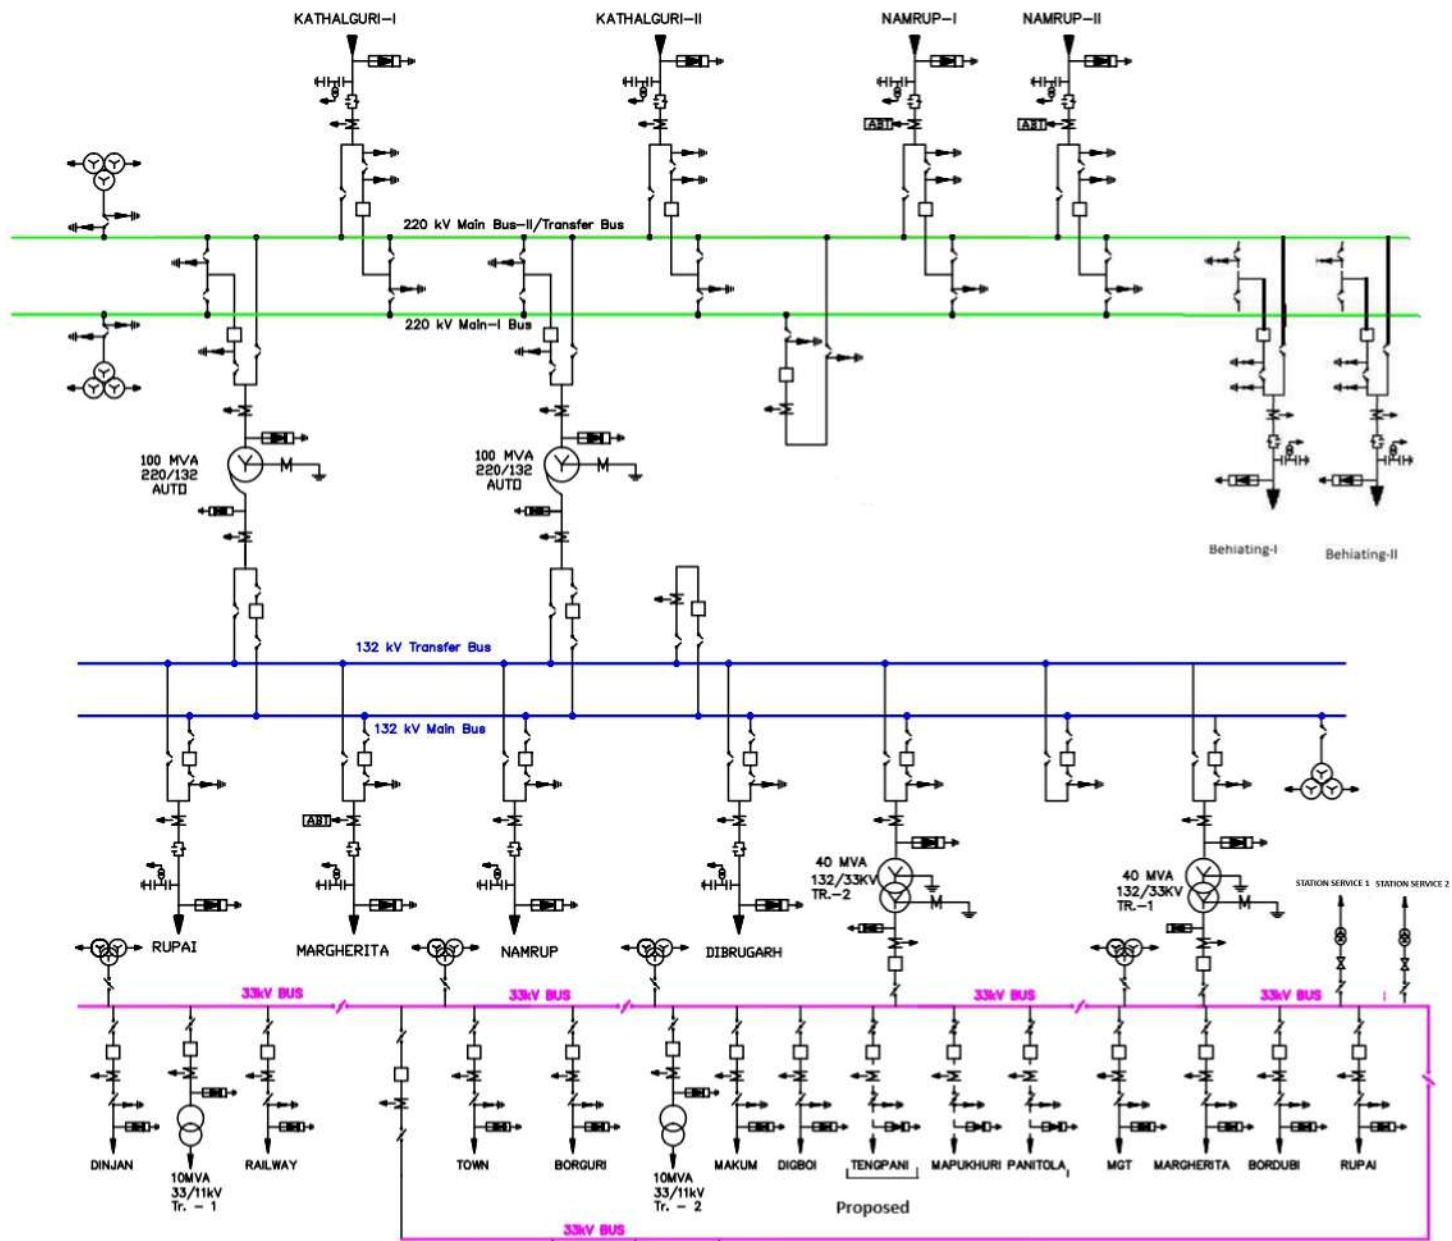

EQUIPMENT LEGENDS

POWER TRANSFORMER	CIRCUIT BREAKER	ISOLATOR WITHOUT EB	ISOLATOR WITH EB	CURRENT TRANSFORMER	POTENTIAL TRANSFORMER	LIGHTNING ARRESTER	WAVE TRAP	CVT

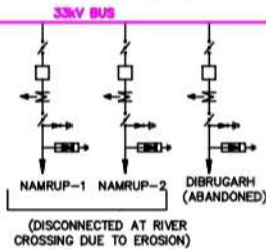

ASSAM ELECTRICITY GRID CORPORATION LIMITED

220/132/33 KV, TINSUKIA SUBSTATION

SINGLE LINE DIAGRAM OF 220/132/33 KV, TINSUKIA SUBSTATION

DRAWING NUMBER: AEGCL/TINSUKIA/SLD/64

Sheet: 1 OF 1